
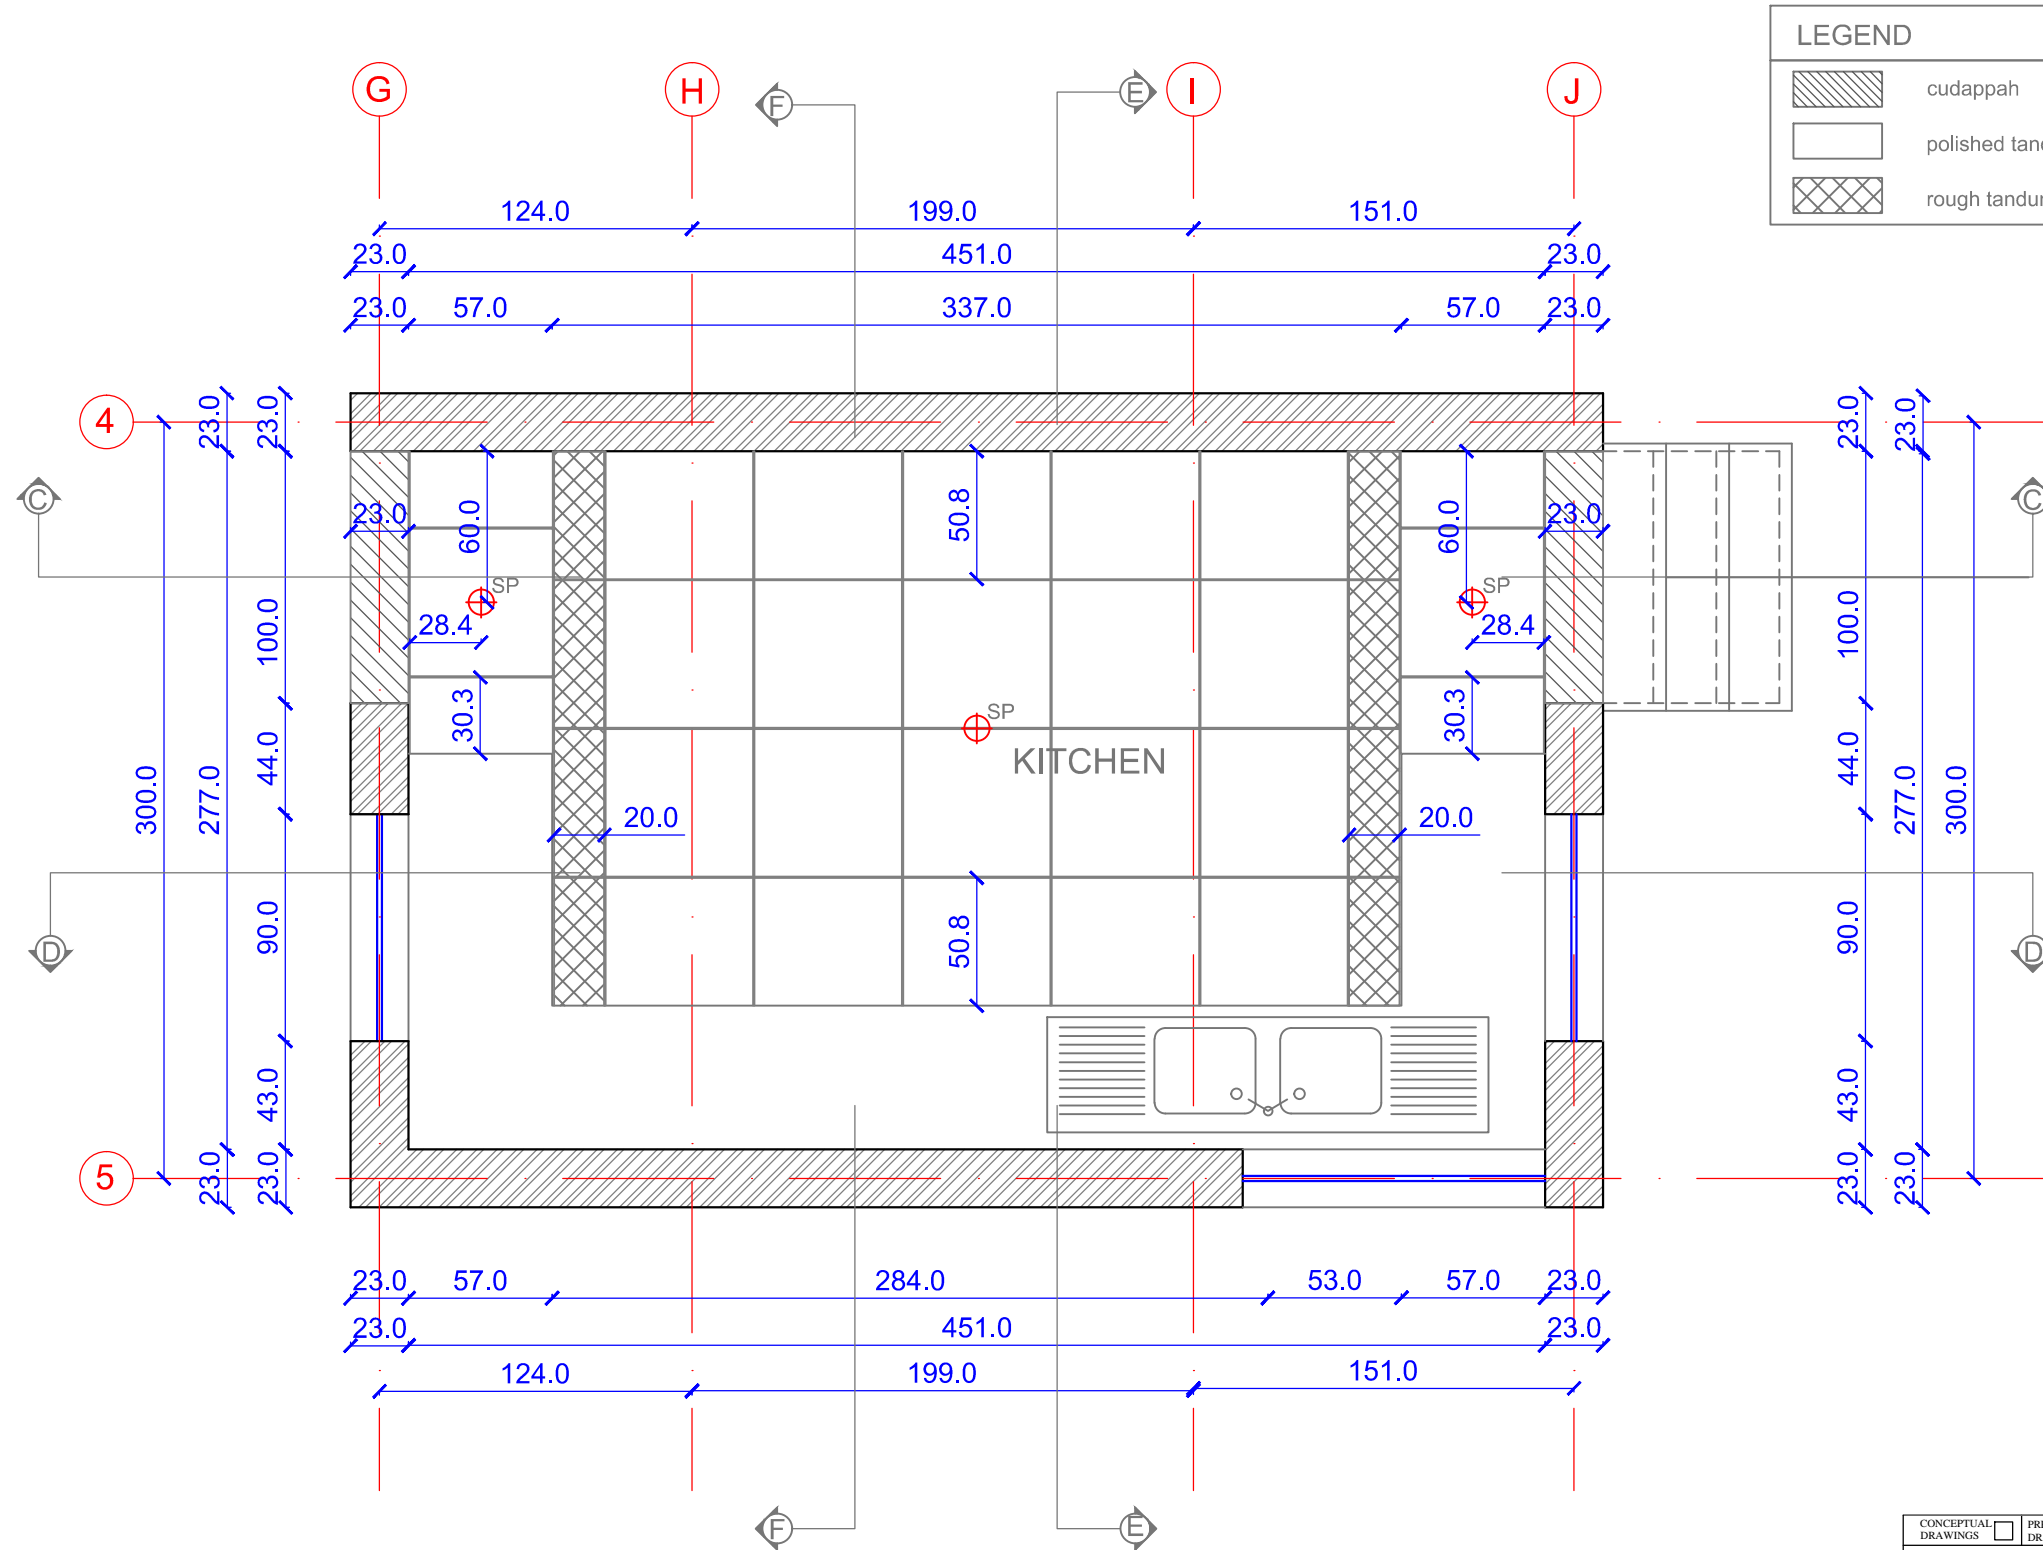





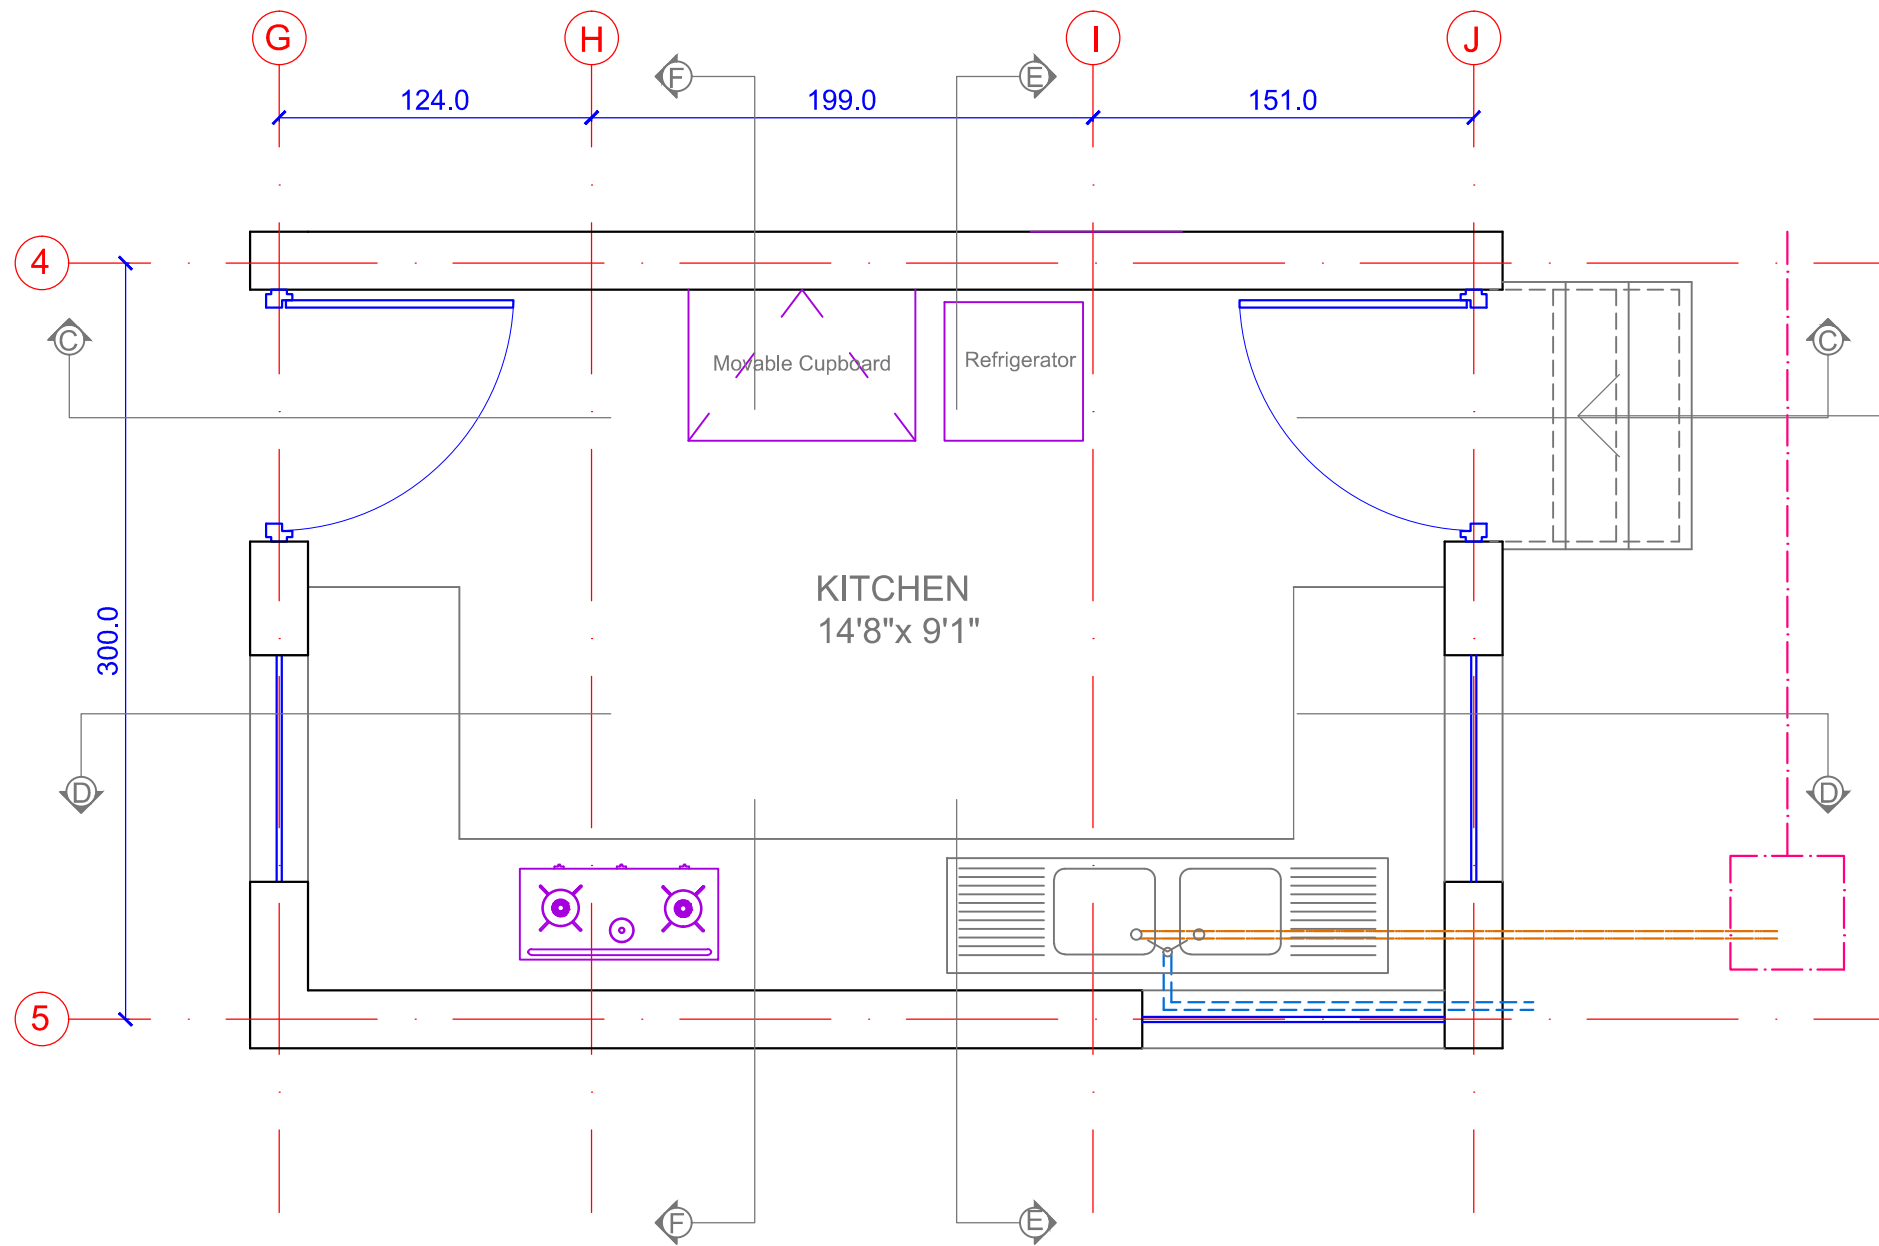
CONCEPTUAL DRAWINGS <input type="checkbox"/>	PRELIMINARY DRAWINGS <input type="checkbox"/>	CONSULTANTS <input checked="" type="checkbox"/>	TENDERING DRAWINGS <input type="checkbox"/>	CONSTRUCTION DRAWINGS <input type="checkbox"/>
ALL DIMENSIONS ARE IN "CM" UNLESS OTHERWISE SPECIFIED				
HARMONY FARM - KITCHEN				
PLAN				
DEALT: RASHA			CHECKED: Ar. SUHASINI	
DATE: 05-03-2016	REVISED DATE:		SCALE: 1:30 - A3	
ISSUED:			DRG NO: AV-HFH-4.1.1	
 PROJECT ARCHITECTS: AUROVILLE DESIGN CONSULTANTS AUROSHILPAM, AUROVILLE - 605101, TAMILNADU				



PLAN

LEGEND	
	cudappah
	polished tandur stone
	rough tandur stone

<input type="checkbox"/> CONCEPTUAL DRAWINGS	<input type="checkbox"/> PRELIMINARY DRAWINGS	<input checked="" type="checkbox"/> CONSULTANTS	<input type="checkbox"/> TENDERING DRAWINGS	<input type="checkbox"/> CONSTRUCTION DRAWINGS
ALL DIMENSIONS ARE IN "CM" UNLESS OTHERWISE SPECIFIED				
HARMONY FARM - KITCHEN				
FLOORING LAYOUT				
DEALT: RASHA		CHECKED: Ar. SUHASINI		
DATE: 05-03-2016	REVISED DATE:	SCALE: 1:30 - A3		
ISSUED:		DRG NO: AV-HFH-4.1.2		
 PROJECT ARCHITECTS:				
AUROVILLE DESIGN CONSULTANTS				
AUROSHILPAM, AUROVILLE - 605101, TAMILNADU				




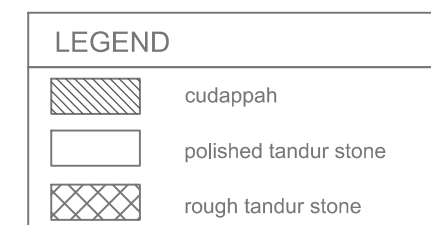
PLUMBING PLAN


LEGEND	
	cold water
	grey water
	external plumbing
	external junction box


CONCEPTUAL DRAWINGS <input type="checkbox"/>	PRELIMINARY DRAWINGS <input type="checkbox"/>	CONSULTANTS <input checked="" type="checkbox"/>	TENDERING DRAWINGS <input type="checkbox"/>	CONSTRUCTION DRAWINGS <input type="checkbox"/>
ALL DIMENSIONS ARE IN "CM" UNLESS OTHERWISE SPECIFIED				
HARMONY FARM - KITCHEN				
PLUMBING LAYOUT				
DEALT: RASHA		CHECKED: Ar. SUHASINI		
DATE: 05-03-2016	REVISED DATE:	SCALE: 1:30 - A3		DRG NO: AV-HFH-4.1.3
ISSUED:		PROJECT ARCHITECTS:		
AUROVILLE DESIGN CONSULTANTS		AUROSHILPAM, AUROVILLE - 605101, TAMILNADU		




CONCEPTUAL DRAWINGS <input type="checkbox"/>	PRELIMINARY DRAWINGS <input type="checkbox"/>	CONSULTANTS <input checked="" type="checkbox"/>	TENDERING DRAWINGS <input type="checkbox"/>	CONSTRUCTION DRAWINGS <input type="checkbox"/>
ALL DIMENSIONS ARE IN "CM" UNLESS OTHERWISE SPECIFIED				
HARMONY FARM - KITCHEN				
ELECTRICAL LAYOUT				
DEALT: RASHA		CHECKED: Ar. SUHASINI		
DATE: 05-03-2016	REVISED DATE:	SCALE: 1:30 - A3		
ISSUED:		DRG NO: AV-HFH.4.1.4		
 PROJECT ARCHITECTS:				
AUROVILLE DESIGN CONSULTANTS AUROSHILPAM, AUROVILLE - 605101, TAMILNADU				





CONCEPTUAL DRAWINGS	<input type="checkbox"/>	PRELIMINARY DRAWINGS	<input type="checkbox"/>	CONSULTANTS	<input checked="" type="checkbox"/>	TENDERING DRAWINGS	<input type="checkbox"/>	CONSTRUCTION DRAWINGS
ALL DIMENSIONS ARE IN "CM" UNLESS OTHERWISE SPECIFIED								
HARMONY FARM - KITCHEN								
SECTION - FF								
DEALT: RASHA				CHECKED: Ar. SUHASINI				
DATE: 05-03-2016		REVISED DATE:		SCALE: 1:30 - A3				
ISSUED:				DRG NO: AV-FHF-4.1.5				
 PROJECT ARCHITECTS:								
AUROVILLE DESIGN CONSULTANTS AUROSHILPAM, AUROVILLE - 605101, TAMILNADU								

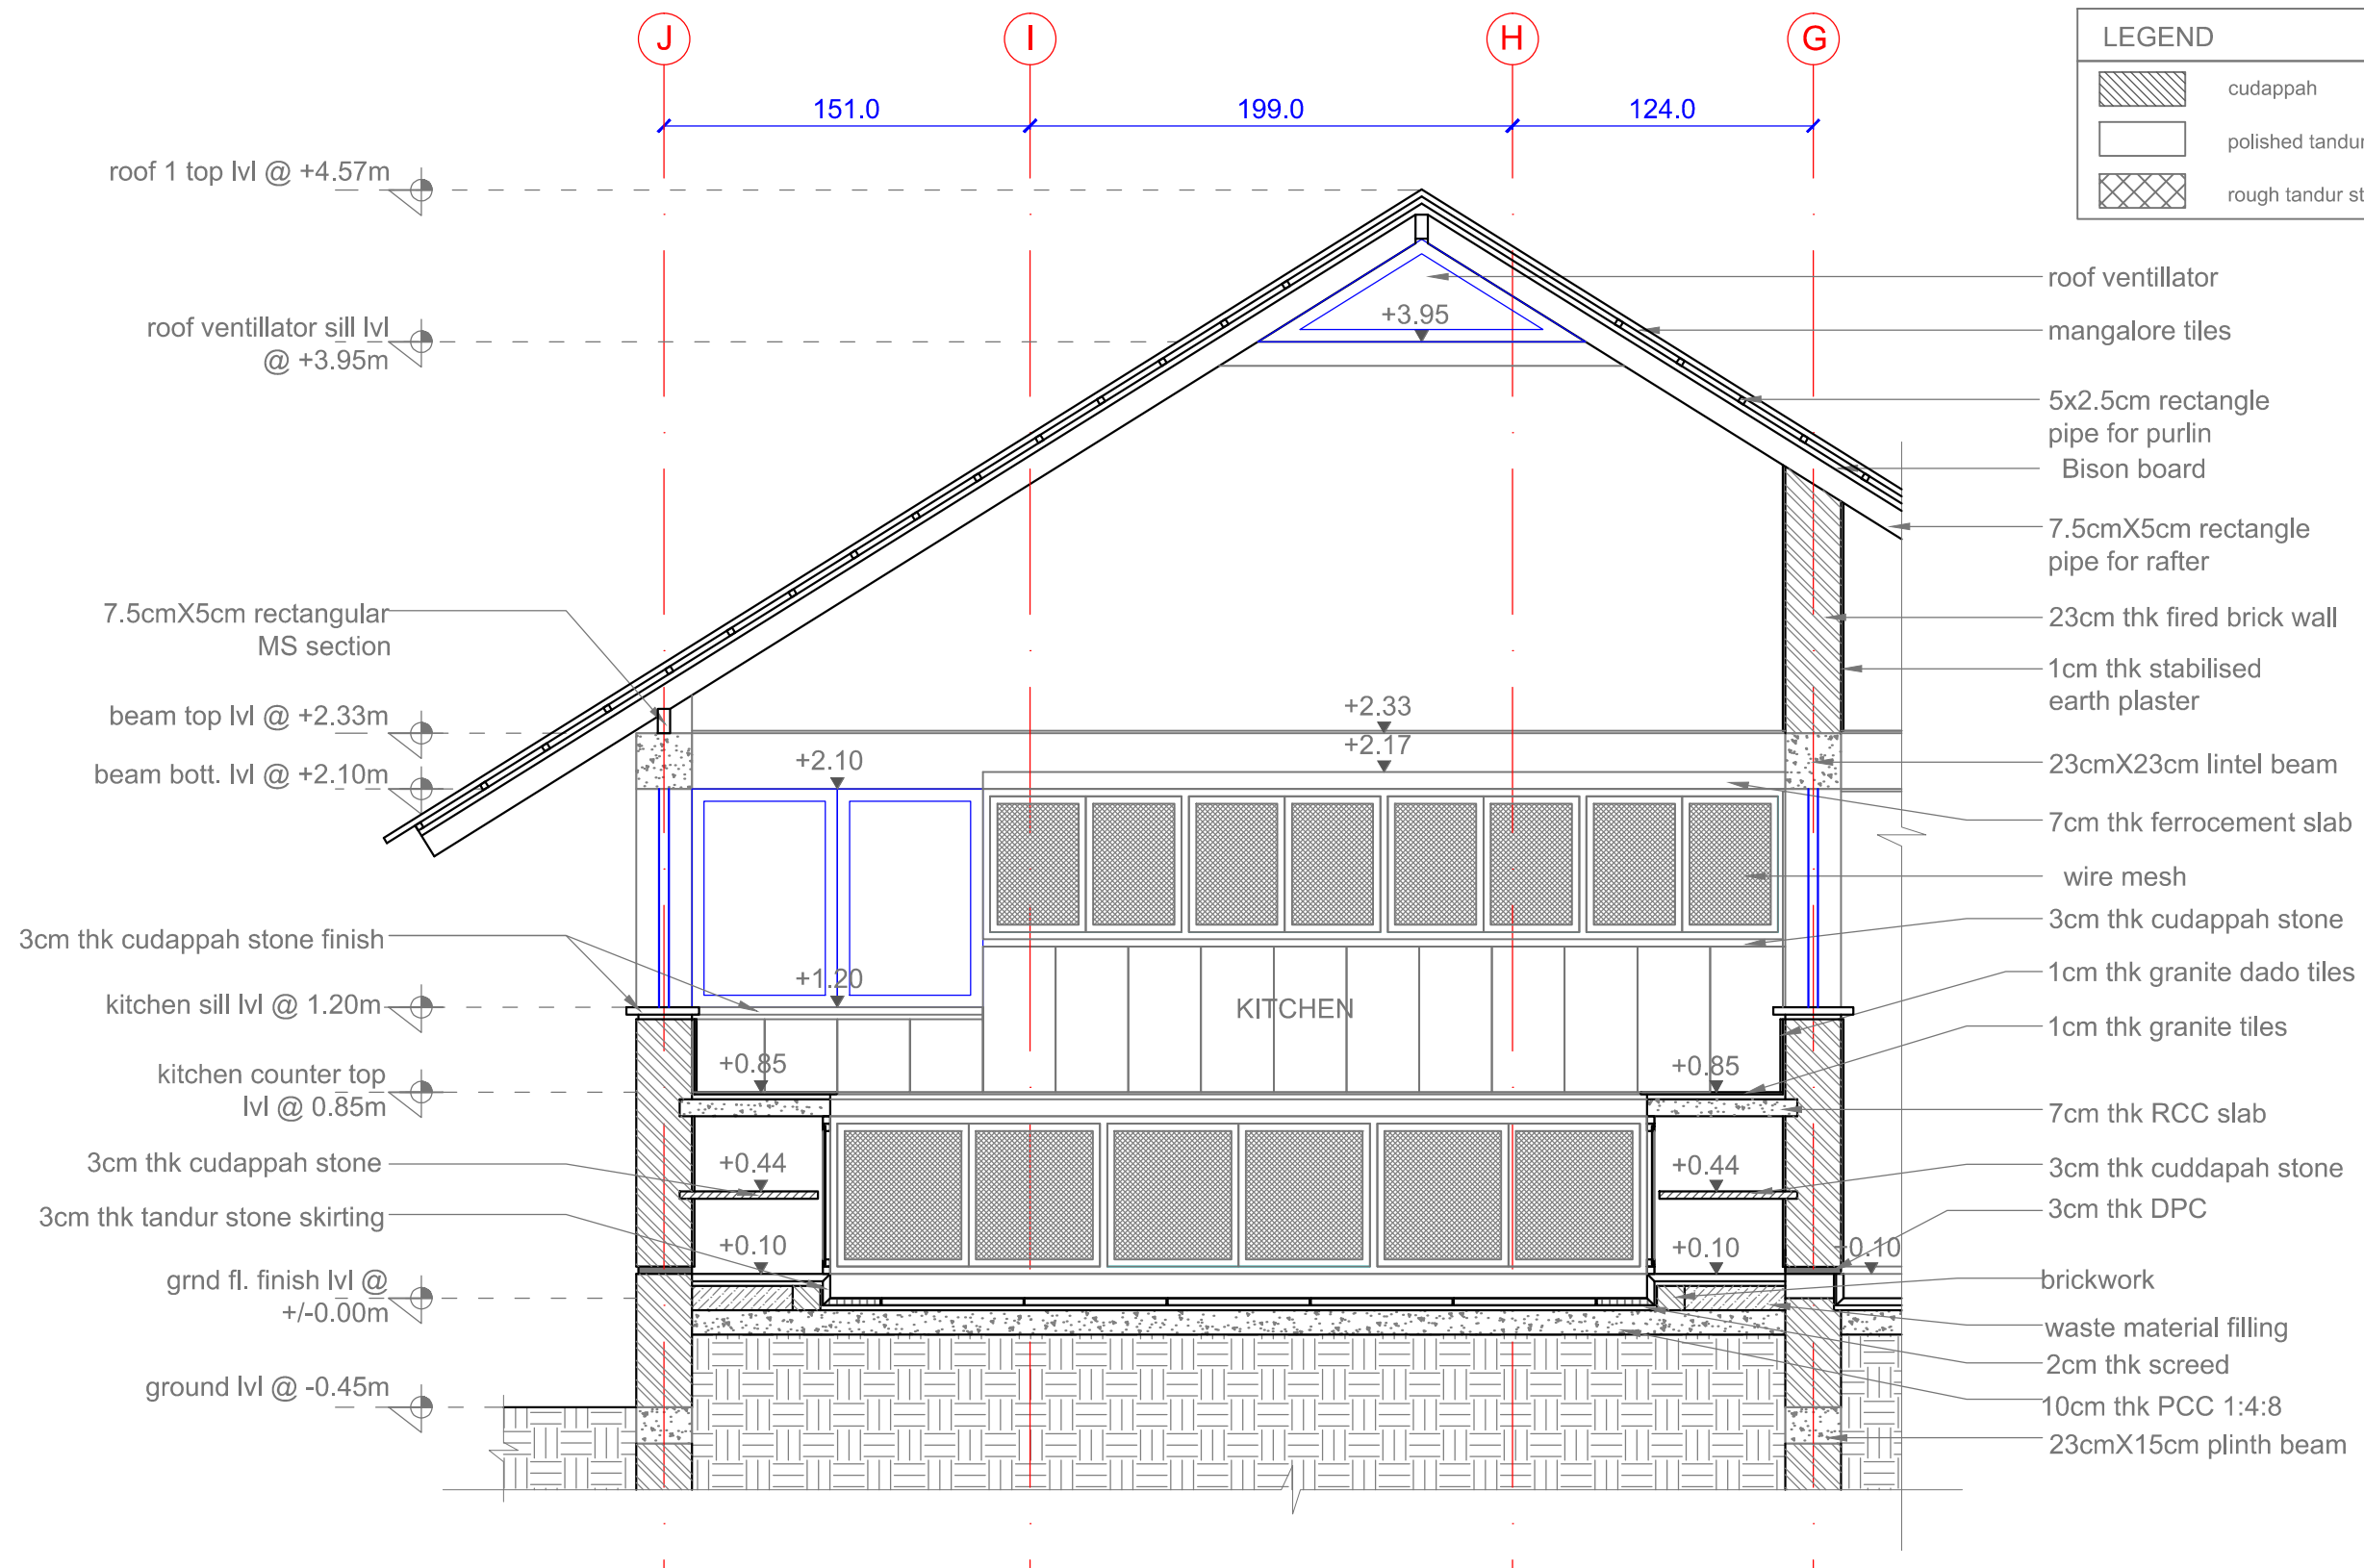

SECTION - DD

CONCEPTUAL DRAWINGS	<input type="checkbox"/>	PRELIMINARY DRAWINGS	<input type="checkbox"/>	CONSULTANTS	<input checked="" type="checkbox"/>	TENDERING DRAWINGS	<input type="checkbox"/>	CONSTRUCTION DRAWINGS	<input type="checkbox"/>
ALL DIMENSIONS ARE IN "CM" UNLESS OTHERWISE SPECIFIED									
HARMONY FARM - KITCHEN									
SECTION - DD									
DEALT: RASHA					CHECKED: Ar. SUHASINI				
DATE: 05-03-2016		REVISED DATE:			SCALE: 1:30 - A3				
ISSUED:					DRG NO: AV-HFH-4.1.6				
PROJECT ARCHITECTS:									
									
AUROVILLE DESIGN CONSULTANTS AUROSHILPAM, AUROVILLE - 605101, TAMILNADU									

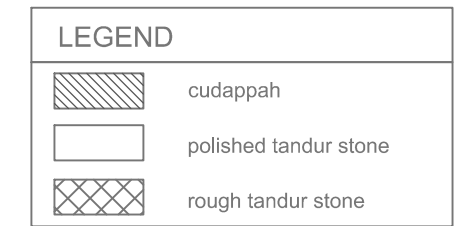

CONCEPTUAL DRAWINGS	<input type="checkbox"/>	PRELIMINARY DRAWINGS	<input type="checkbox"/>	CONSULTANTS	<input checked="" type="checkbox"/>	TENDERING DRAWINGS	<input type="checkbox"/>	CONSTRUCTION DRAWINGS	<input type="checkbox"/>
ALL DIMENSIONS ARE IN "CM" UNLESS OTHERWISE SPECIFIED									
HARMONY FARM - KITCHEN									
SECTION - EE									
DEALT: RASHA					CHECKED: Ar. SUHASINI				
DATE: 05-03-2016		REVISED DATE:			SCALE: 1:30 - A3				
ISSUED:					DRG NO: AV-HFH-4.1.7				
 PROJECT ARCHITECTS:									
AUROVILLE DESIGN CONSULTANTS AUROSHILPAM, AUROVILLE - 605101, TAMILNADU									

